
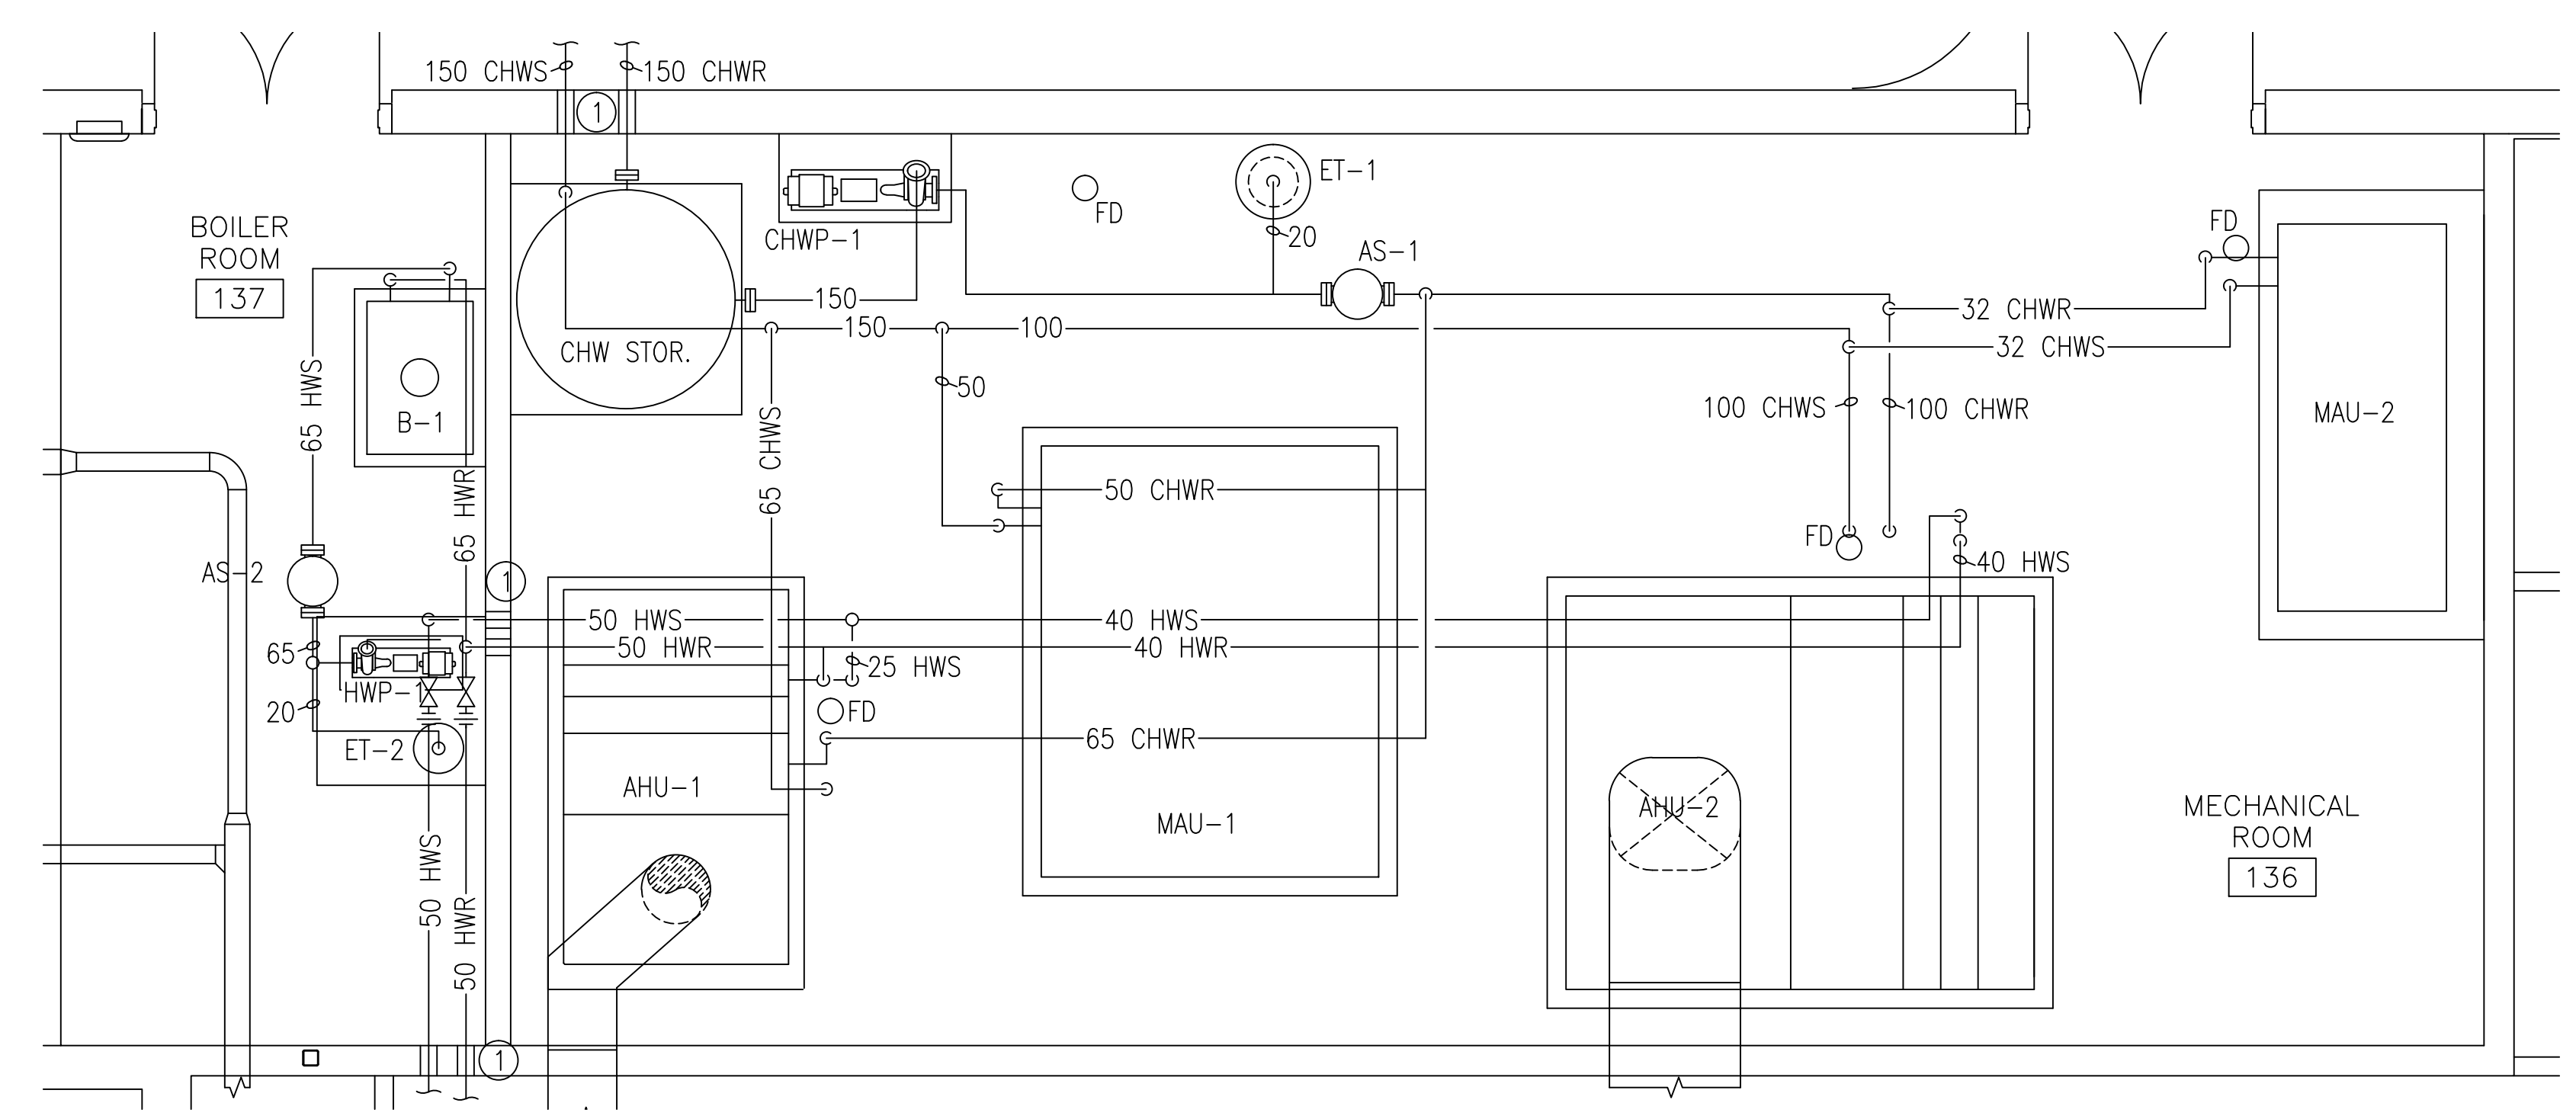


REVISIONS					
REVISION SYMBOL	NO. SYMS.	AMD. C.O.R.	DESCRIPTION	DATE	APPROVED

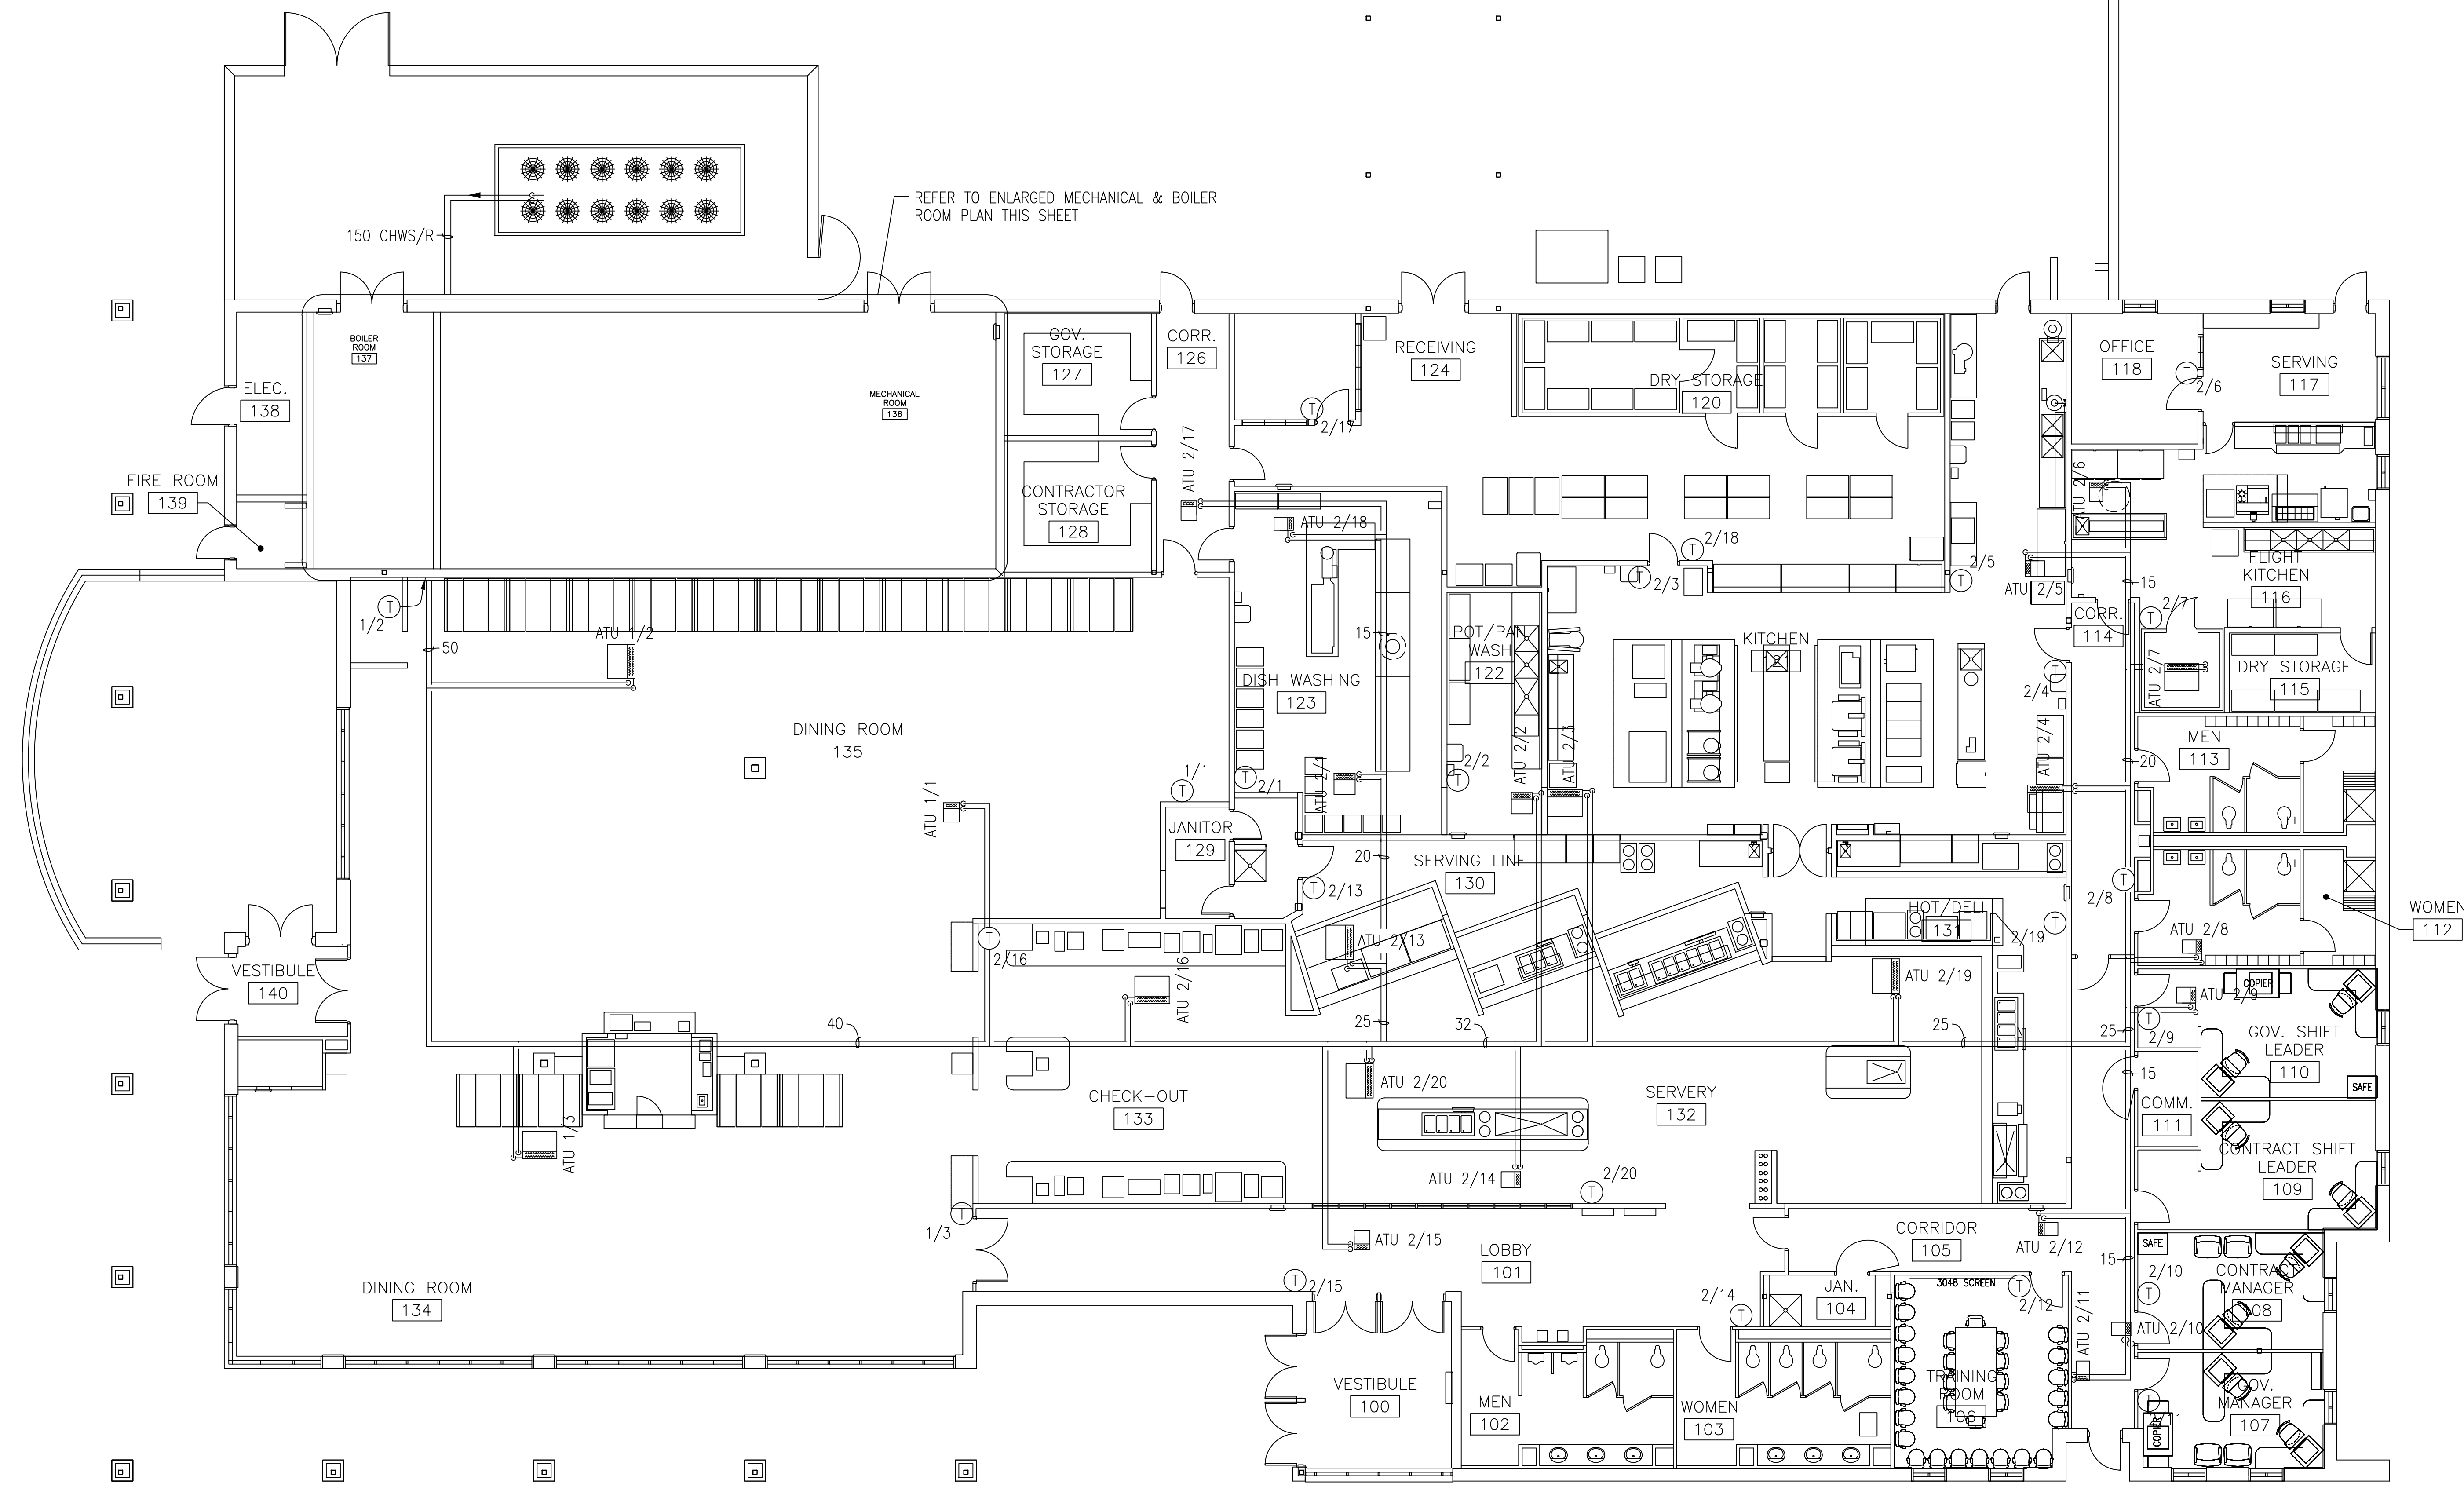

**'AS-BUILT'**  
JANUARY, 2003

DESIGNED BY: R. CANEKERATNE	BULLOCK TICE ASSOCIATES 909 E. CERVANTES ST., SUITE B PENSACOLA, FL. 32501	U.S. ARMY ENGINEER DISTRICT, MOBILE CORPS OF ENGINEERS MOBILE, ALABAMA
DRAWN BY: A. REMSKI	EGLIN AIR FORCE BASE, FLORIDA FY-00 EGLIN DINING FACILITY	
CHECKED BY: R. CANEKERATNE	HVAC PIPING PLAN	
SUPERVISED BY: G. PETERSON	SH REF NO M-102	CADD FILE NAME 277M102F.DWG
	FILE NO.: EGL-229-63	CONTRACT NO.: DACA01-00-C-0042
	DATE: APRIL 11, 2001	